


WAKE COUNTY COMMONS CONFERENCE CENTER

DRAWING INDEX	
AUDIOVISUAL SYSTEMS DRAWINGS	
NUMBER	DESCRIPTION
AVS00	AUDIOVISUAL SYSTEMS COVER SHEET
AVS01	AUDIOVISUAL SYSTEMS

CONTRACTOR RESPONSIBILITY MATRIX		
ITEM / TASK	FURNISH	INSTALL
CONDUIT, WALL BOXES, CEILING BOXES, FLOOR BOXES, AND OTHER CABLE PATHWAYS REQUIRED TO SUPPORT AV SYSTEMS.	OT	OT
PROJECTION SCREENS - CASE	OT	OT
PROJECTION SCREENS - ROLLER/FABRIC	OT	OT
IN-WALL BLOCKING, CEILING SUPPORT STRUCTURE, AND OTHER STRUCTURAL SUPPORT FOR AV EQUIPMENT.	OT	OT
AV EQUIPMENT	AVC	AVC
AV CABLING AND TERMINATIONS	AVC	AVC
AV CONTROL SYSTEM AND DSP SOFTWARE DEVELOPMENT	AVC	AVC
AV EQUIPMENT CONFIGURATION, TESTING, COMMISSIONING, TRAINING, AND PROJECT ACTIVATION	AVC	AVC
TV DISTRIBUTION INTRA-BUILDING CABLING/DISTRIBUTION	OT	OT
STRUCTURED CABLING (FOR BUILDING NETWORK) AND TERMINATIONS	OT	OT
STRUCTURED CABLING (FOR AV NETWORK) AND TERMINATIONS	AVC	AVC
MOUNTS, EQUIPMENT RACKS, AND INSTALLATION MATERIALS	AVC	AVC
LECTERN / AV OPERATOR CONSOLE CONTAINING AV EQUIPMENT	AVC	AVC
CREDENZA / OTHER FURNITURE CONTAINING AV EQUIPMENT	AVC	AVC
SITE MILL-WORK	OT	OT
CABLE MANAGEMENT AND BOXES FOR AV EQUIPT. IN CONFERENCE TABLES/FURNITURE	AVC	AVC
MODIFICATIONS TO CONFERENCE TABLES/FURNITURE FOR AV EQUIPMENT	OT	OT
COMPUTERS AND OTHER OWNER-FURNISHED EQUIPMENT	O	AVC
RESPONSIBLE PARTIES:		
AVC AUDIOVISUAL CONTRACTOR	O OWNER	
C CONSULTANT	OT OTHER TRADES	
NOTES:		
THIS MATRIX IS PROVIDED AS A CONVENIENCE TO THE CONTRACTOR AND TO DRAW PARTICULAR ATTENTION TO ITEMS THAT REQUIRE SPECIFIC COORDINATION FROM MULTIPLE PARTIES. THIS IS NOT AN ALL-INCLUSIVE LIST. CONTRACTOR SHALL REFERENCE THE AUDIOVISUAL SPECIFICATION FOR COMPLETE REQUIREMENTS. IF THERE ARE ANY DISCREPANCIES BETWEEN THIS AND THE SPECIFICATION, THE SPECIFICATION SHALL TAKE PRECEDENCE.		

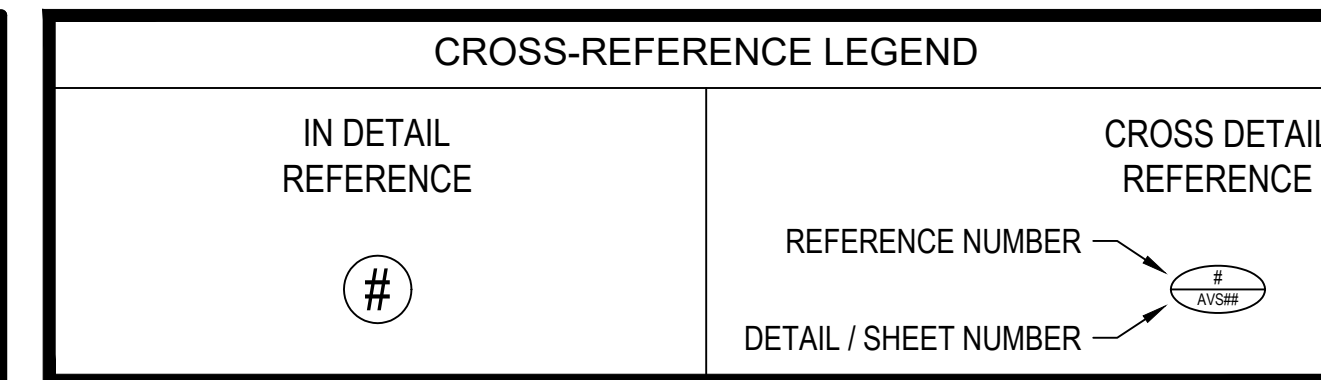

Stamp

REVISIONS

DESCRIPTION	DATE

Project No.: 3543.01
 Checked By: OC
 Designed By: DF
 Drawn By: DF
 Date: 03/11/24

SHEET NAME
AUDIOVISUAL SYSTEMS COVER SHEET

WAKE COUNTY COMMONS CONFERENCE CENTER

SHEET NUMBER
AVS00

JOB NUMBER

Stamp


REVISIONS	DATE

Project No.: 3543.01
Checked By: OC
Designed By: DF
Drawn By: DF
Date: 03/11/24

WAKE COUNTY COMMONS CONFERENCE CENTER

AVS01

JOB NUMBER

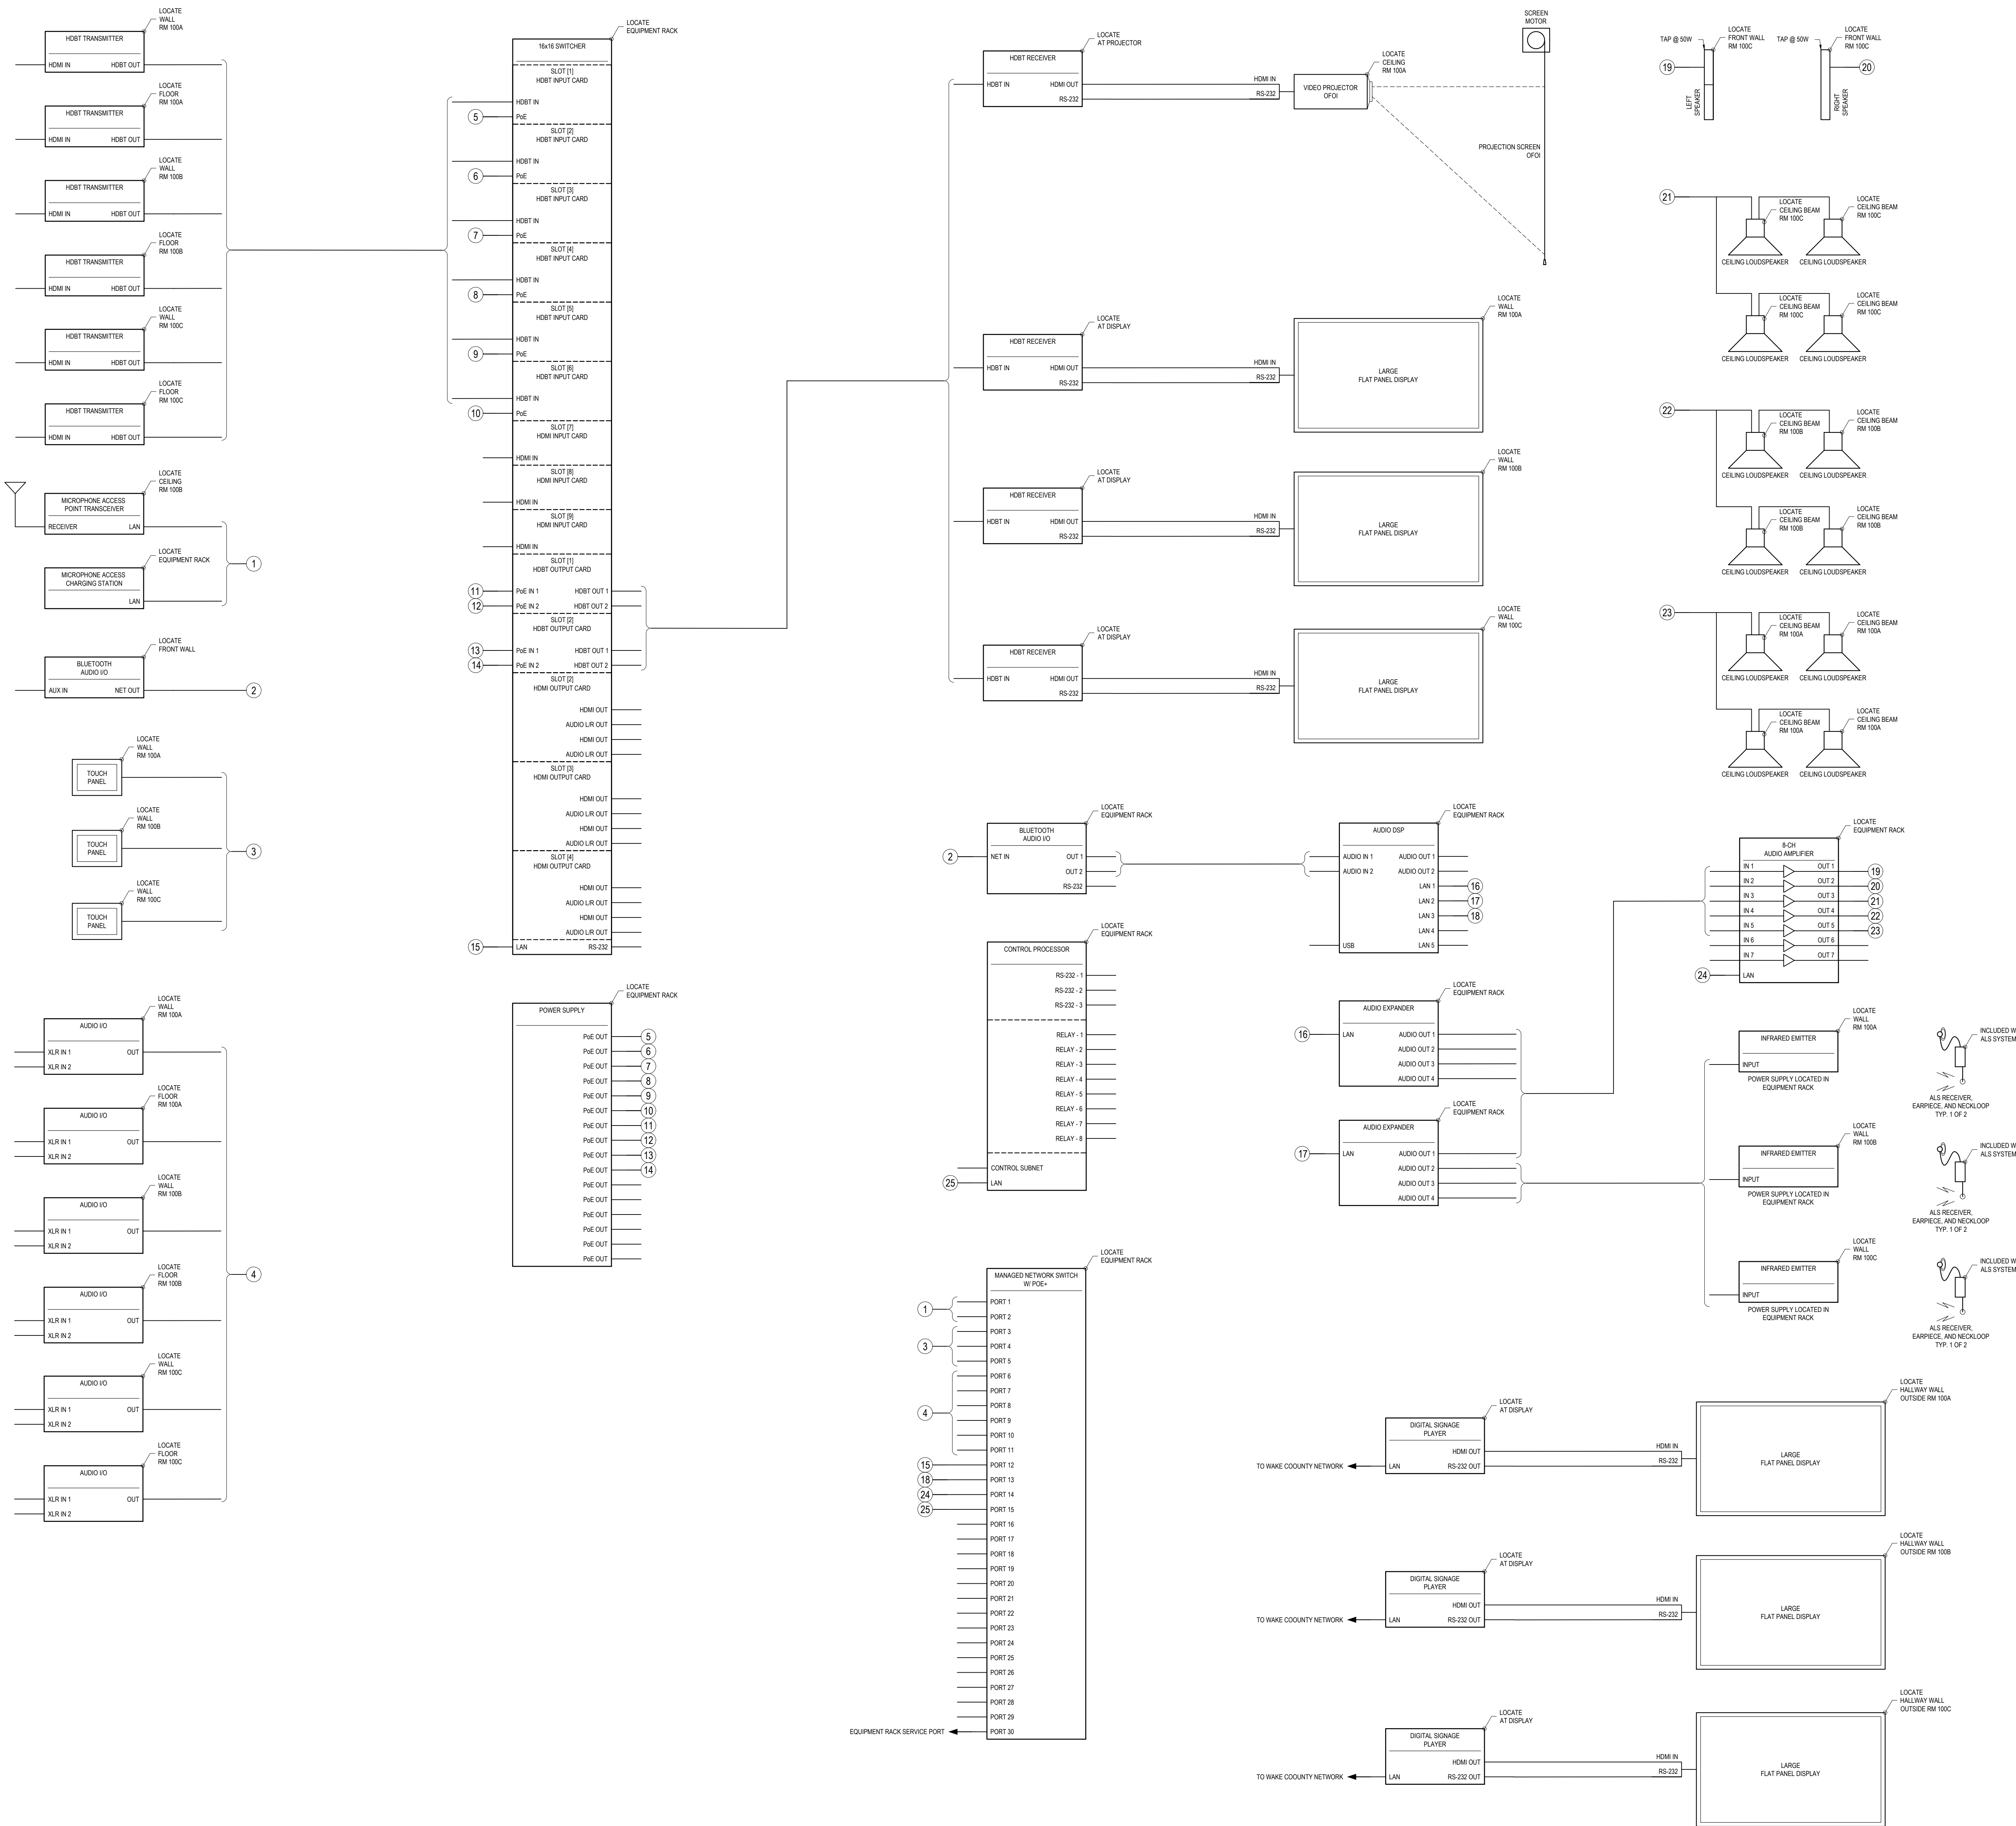

P:\3500-5599\3543.01 - Wake County Commons Configuration\IPDrawings\AV Systems\Commons\3543.01 - Wake County Commons Configuration\System Drawings\031124.dwg
3/11/2024 12:28:16 PM

1 SY01 - CONFERENCE ROOM - ROOM NUMBERS 100A, 100B, 100C
SCALE: NTS